



LEGEND:

- PROPOSED FOUL WATER DRAINAGE AND MANHOLE
- PROPOSED BACKDROP MANHOLE
- PROPOSED INSPECTION CHAMBER
- PROPOSED RISING MAIN
- EXISTING COMBINED SEWER AND MANHOLE
- SERVICE CONNECTION
- FLOOR GULLY
- PROPOSED DIVERSION OF EXISTING COMBINED DRAINAGE

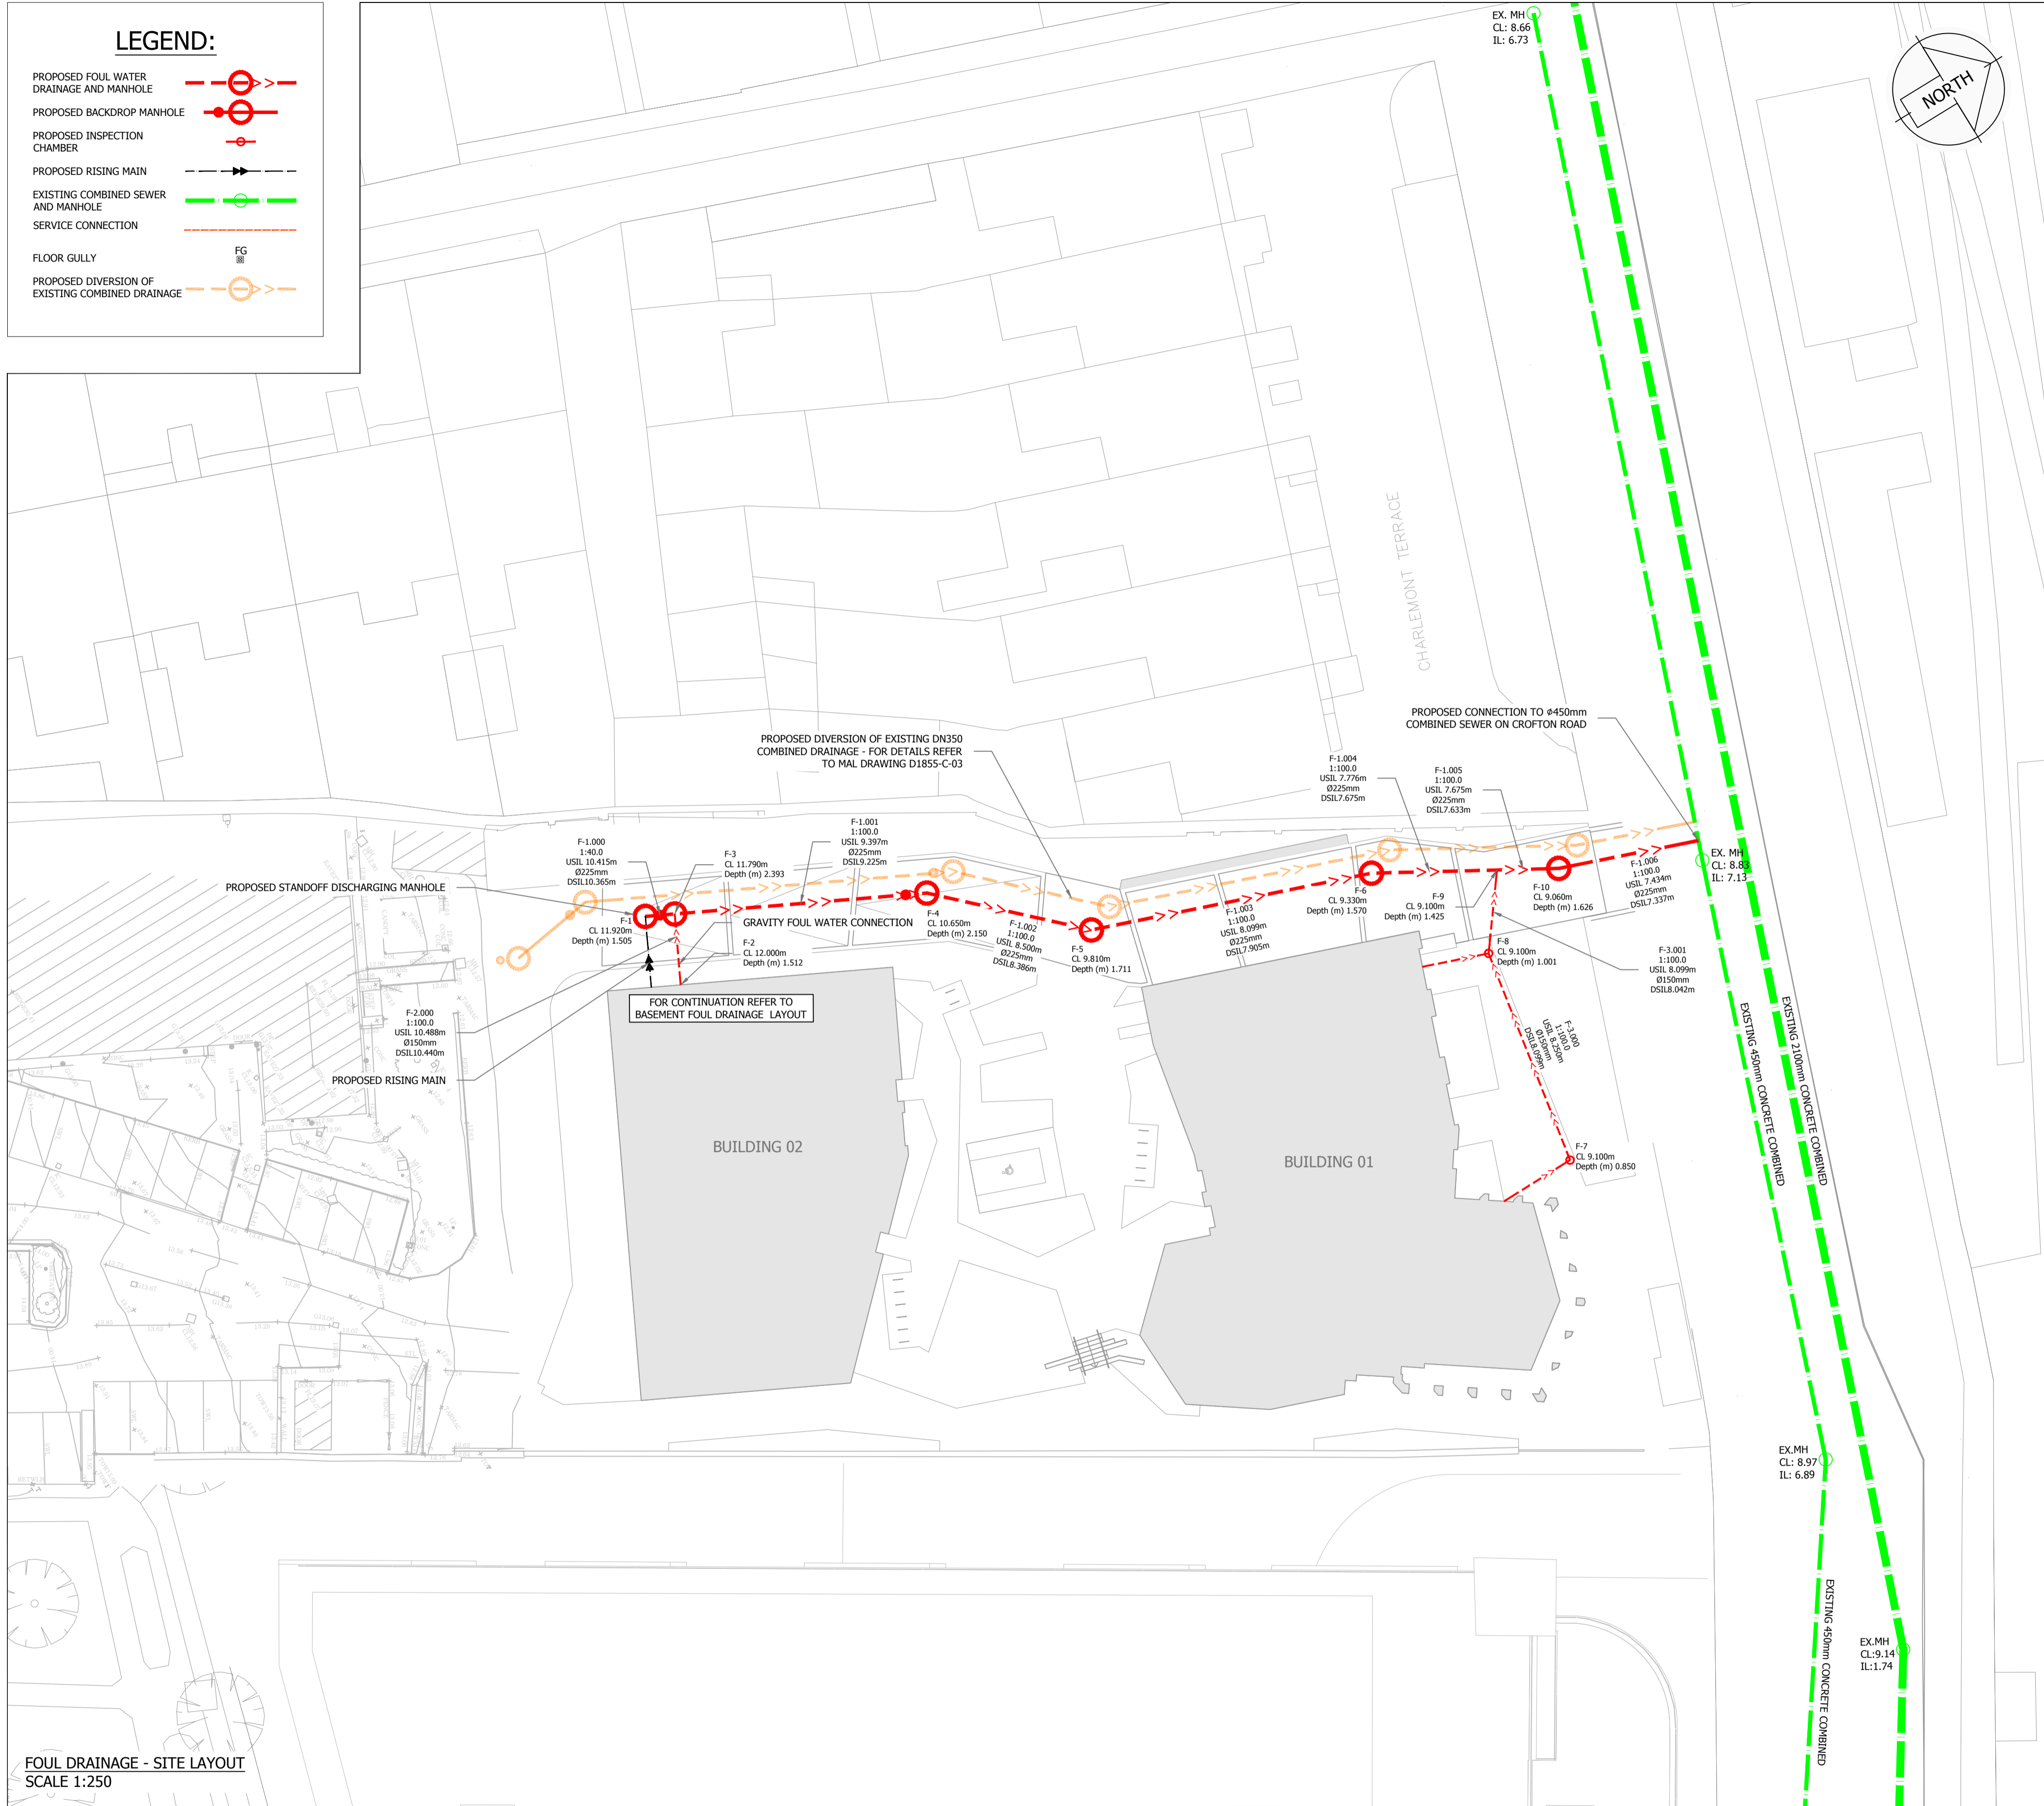

FOUL DRAINAGE - SITE LAYOUT
SCALE 1:250

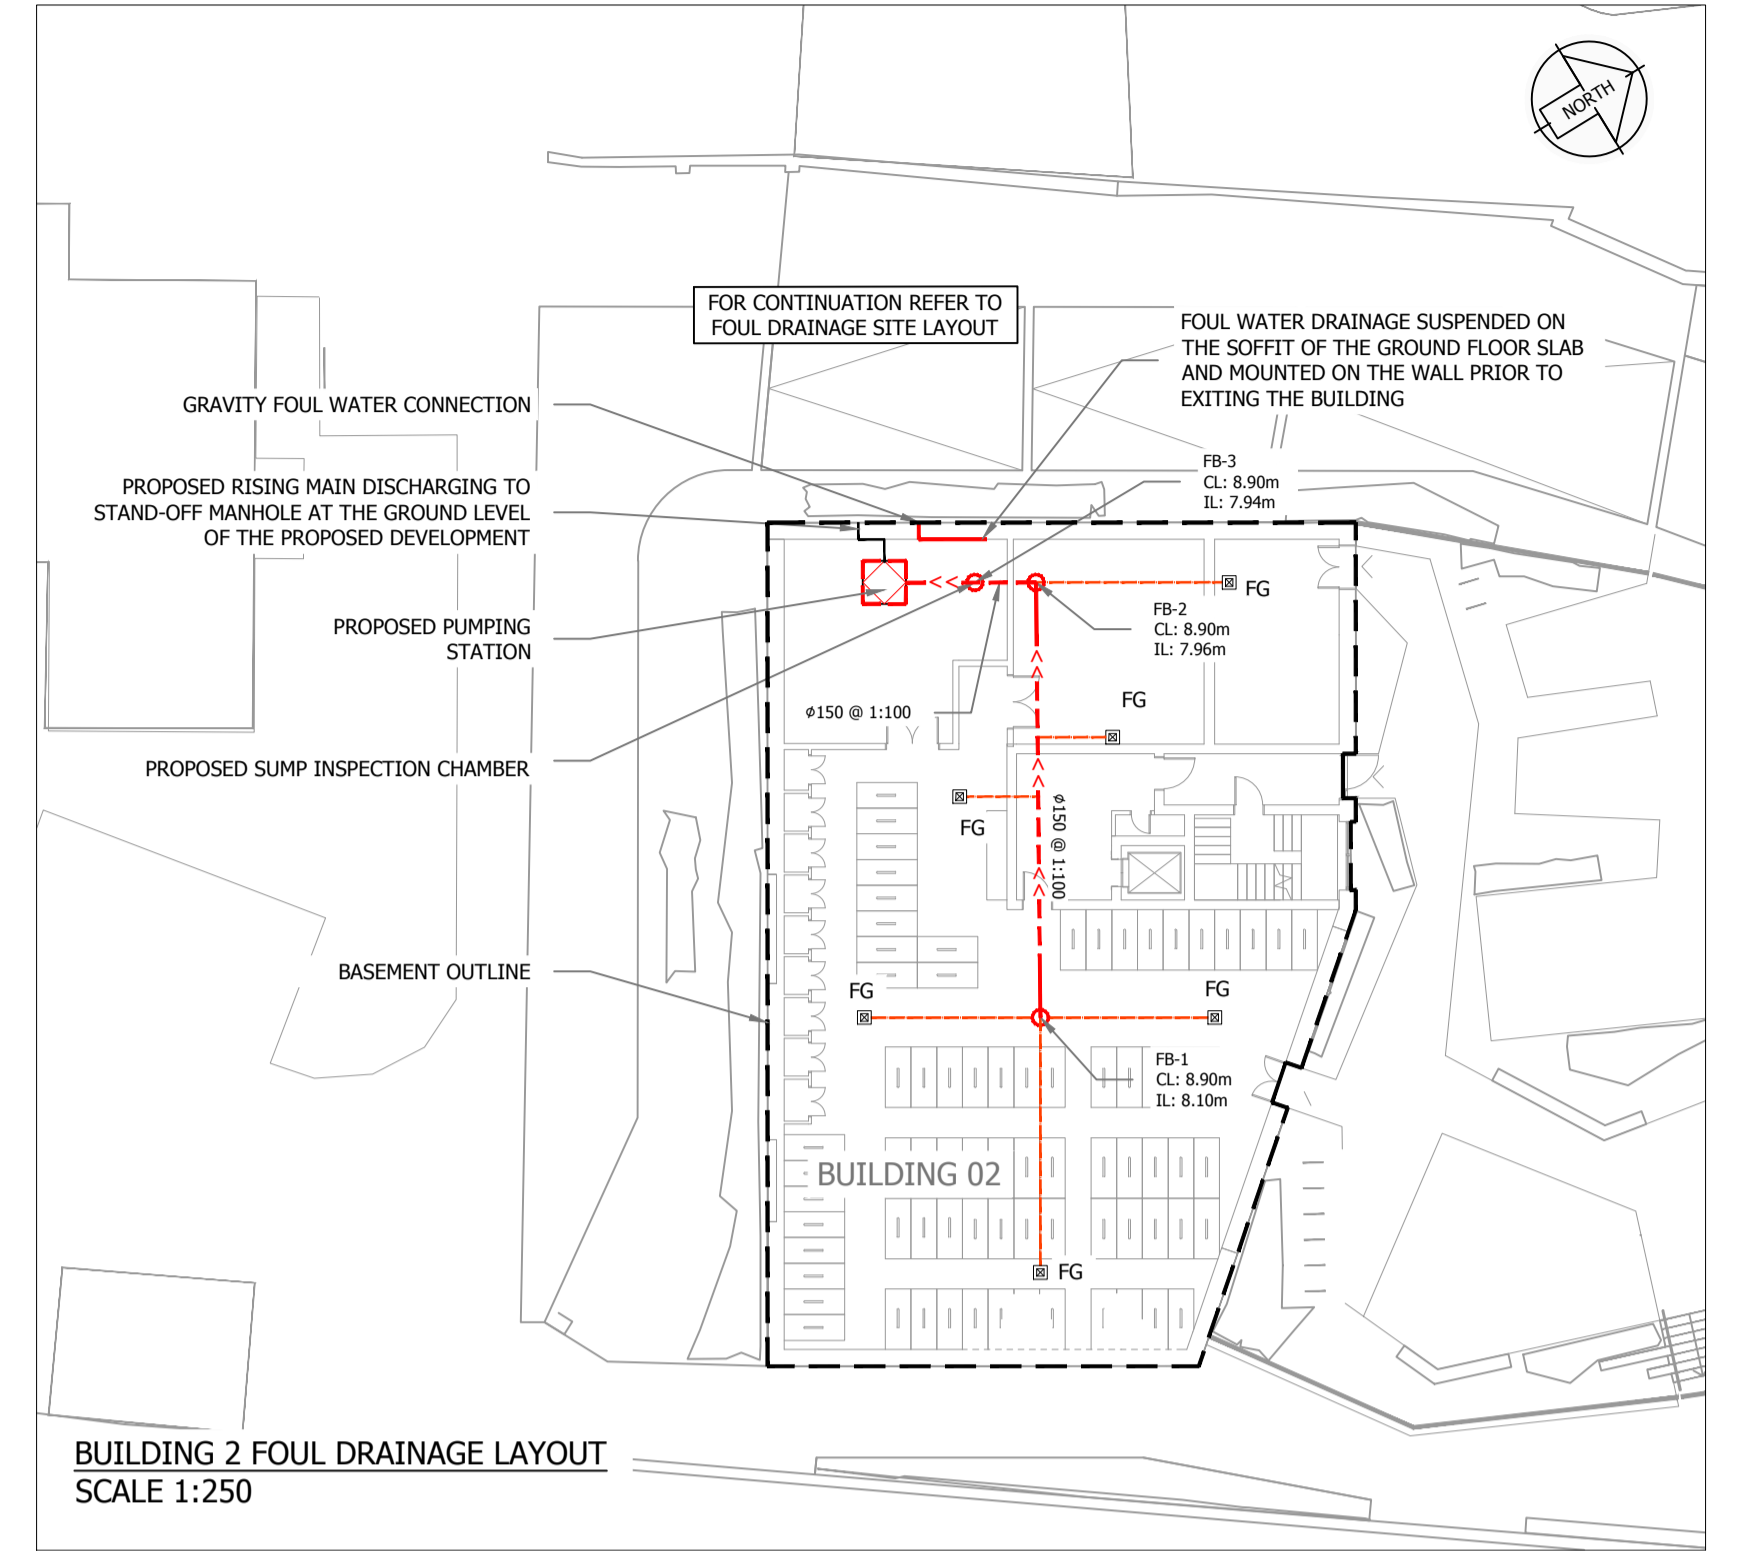

BUILDING 2 FOUL DRAINAGE LAYOUT
SCALE 1:250

PLANNING

Copyright
No part of this document may be reproduced or transmitted in any form or stored in any retrieval system of any nature without the written permission of Muir Associates Ltd. as copyright holder except as agreed for use on the project for which the document was originally issued.

- NOTES:**
1. ALL LEVELS ARE IN METERS UNLESS NOTED OTHERWISE
 2. ALL PRIMARY DRAINAGE DETAILS ARE TO COMPLY WITH THE REQUIREMENT OF IRISH WATER CODE OF PRACTICE.
 3. ALL ON PLOT PRIVATE DRAINAGE TO BE IN ACCORDANCE WITH BUILDING REGULATIONS TECHNICAL GUIDANCE DOCUMENT H.
 4. PIPEWORK MATERIAL uPVC AND IS TO COMPLY WITH SECTION 3.13 OF IRISH WATER CODE OF PRACTICE FOR WASTE WATER INFRASTRUCTURE.

Ordnance Survey Ireland Licence No.
EN 0001720 © Government of Ireland

REVISION	DATE	DESCRIPTION	REV BY	CHK BY
A	18.09.20	ISSUED TO IRISH WATER	SC	SS
B	21.10.20	ISSUED FOR PLANNING	SC	SS

Consulting Engineers
Project Managers
MUIR ASSOCIATES
Marketing Network House,
Aniyle Square,
Morehampton Road,
Dublin D04 K0Y1, Ireland
Telephone: +353-1-6762788
email: info@muir.ie www.muir.ie

PROJECT ST. MICHAELS DEVELOPMENT, DÚN LAOGHAIRE		CLIENT FITZWILLIAM DL LTD		TITLE FOUL WATER DRAINAGE LAYOUT	
Director SOR	Proj. Eng. SS	Drawn by SC	DRG. No.	REV	
Scale AS SHOWN @A1	Checked SOR	Date SEP '20	D1855-C-05	B	